



© IAAF 2016™

EXHIBIT “A”



Countdown Clock for IAAF World Indoor Championships Portland 2016

Portland, Oregon, USA

Portland City Council Package

APRIL 20, 2015




TRACKTOWN USA

2016 IAAF World Championships
Countdown Clock

APRIL 20, 2015
DATE

PORTLAND CITY COUNCIL PACKAGE

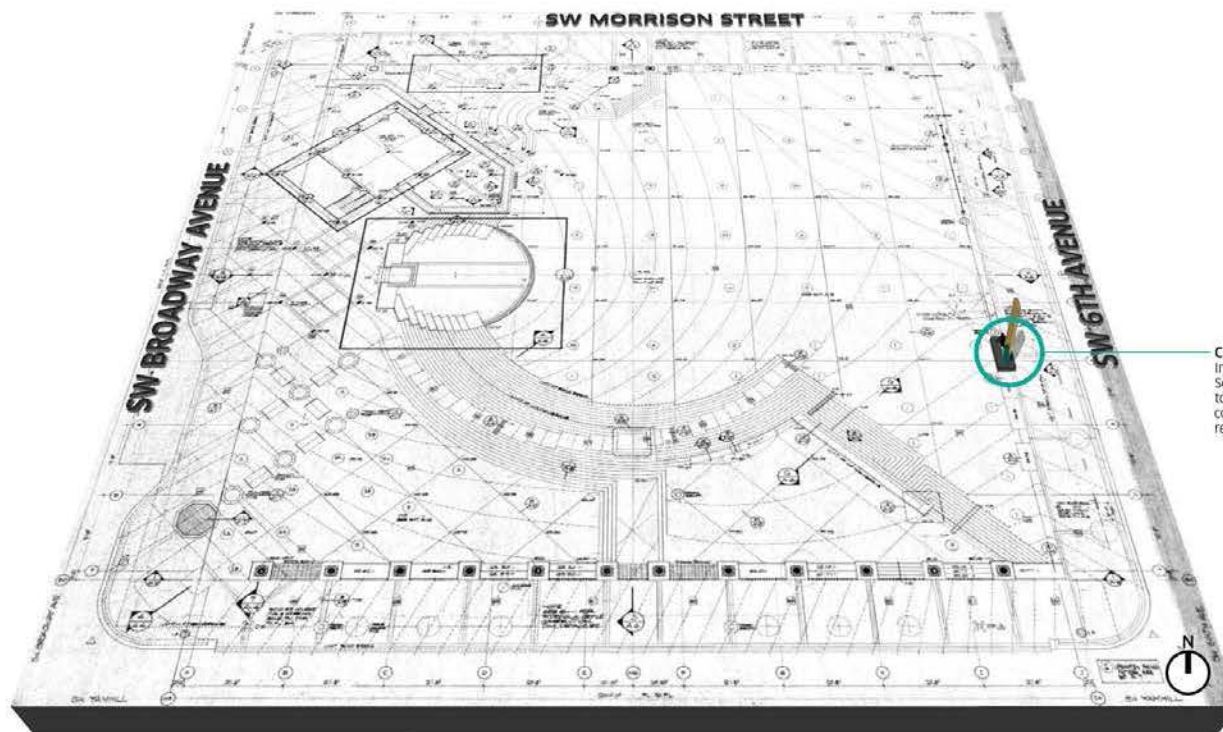

Clock Location

Installed on top of existing masonry bench.
See note 3/A10 for bench section. Engineer
to inform any necessary testing of existing
conditions. Sponsor to perform testing as
requested by engineer.

PIONEER COURTHOUSE SQUARE
Portland, Oregon

downstream

1624 NW JOHNSON STREET
PORTLAND, OR 97209
USA
T: 503.226.1944
WWW.DOWNSTREAM.COM

These drawings are for the sole purpose
of increasing visual design intent and are not
intended for construction purposes. All aspects
of engineering, fabrication, installation, and any
resulting documentation are the responsibility of
the fabricator and/or installer.

SHEET NAME:
SITE PLAN

SHEET NO.
1.00-02

REVISION

1

1 SITE PLAN
SCALE: NTS



Blade Sign
Painted Metal Sign with Static Applied
Graphics Slotted Into Upper Cladding
Panels

Lower Cladding Panels
Graphic Wrapped Panels; Event Specific
Graphics and Messaging

Upper Cladding Panels
Graphic Wrapped Panels with Translucent
Infill Panel, LED Array Behind



Plinth Cladding Panels
Painted Metal Panels with Applied
Sponsor Graphics



TRACKTOWN USA

2016 IAAF World Championships
Countdown Clock

APRIL 20, 2015
DATE

PORTLAND CITY COUNCIL PACKAGE

downstream

1624 NW JOHNSON STREET
PORTLAND, OR 97209
USA
T. 503.226.1944
WWW.DOWNSTREAM.COM


These drawings are for the sole purpose
of expressing visual design intent and are not
intended for construction purposes. All aspects
of engineering, fabrication, installation, and any
resulting documentation are the responsibility of
the fabricator and/or installer.

SHEET NAME:
OVERVIEW


SHEET NO.
1.00-01

REVISION
1

1 OVERALL 3D VIEWS
SCALE: NTS

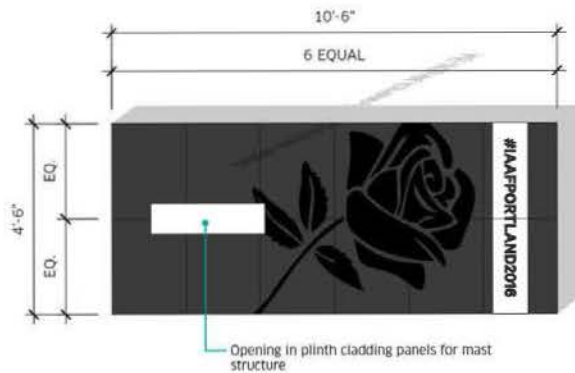

2 PLINTH PLAN VIEW
SCALE: 3/8" = 1'-0"

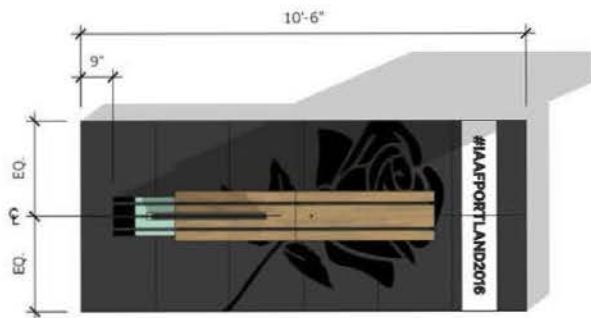

3 TOP PLAN VIEW
SCALE: 3/8" = 1'-0"



1 AERIAL 3D VIEW
SCALE: NTS



TRACKTOWN USA

2016 IAAF World Championships
Countdown Clock

APRIL 20, 2015
DATE:

PORTLAND CITY COUNCIL PACKAGE

downstream


1624 NW JOHNSON STREET
PORTLAND, OR 97209
USA
T: 503.236.1544
WWW.DOWNSTREAM.COM

These drawings are for the sole purpose of expressing visual design intent and are not intended for construction purposes. All aspects of engineering, fabrication, installation, and any resulting documentation are the responsibility of the fabricator and/or installer.

SHEET NAME:
PLANS

SHEET NO.
2.00-01

REVISION
1

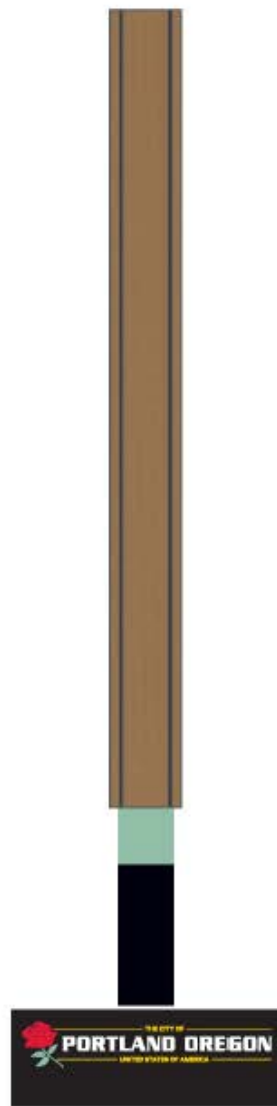



TRACKTOWN USA

2016 IAAF World Championships
Countdown Clock

APRIL 20, 2015
DATE

PORTLAND CITY COUNCIL PACKAGE

downstream



1624 NW JOHNSON STREET
PORTLAND, OR 97209
USA
T: 503.226.1944
WWW.DOWNSTREAM.COM

These drawings are for the sole purpose of expressing visual design intent and are not intended for construction purposes. All aspects of engineering, fabrication, installation and any resulting documentation are the responsibility of the fabricator and/or installer.

SHEET NAME:
CLOCK SPONSORSHIP AREAS

SHEET NO:
6.00-01

REVISION
1

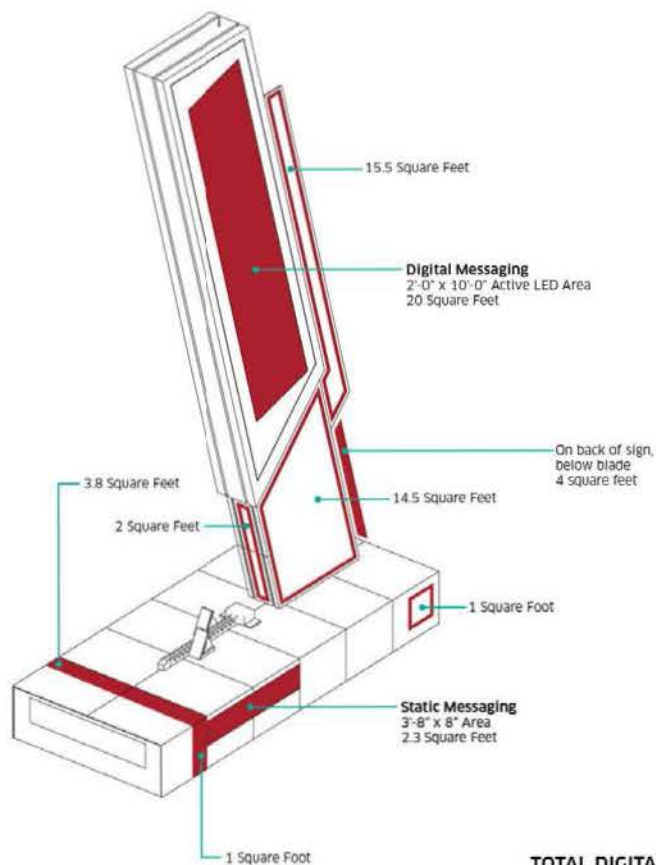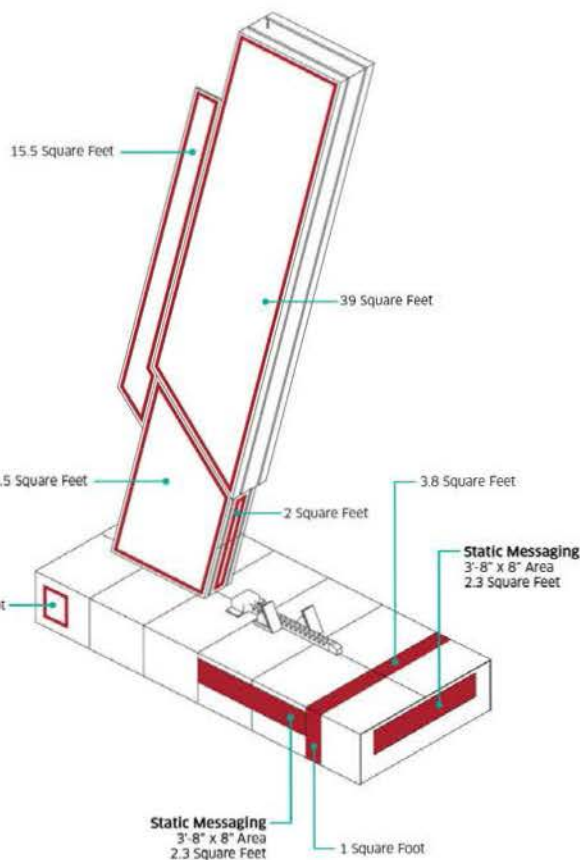

TOTAL DIGITAL: 20 Square Feet
TOTAL STATIC: 119.7 Square Feet

1 SPONSORSHIP AREAS
SCALE: 1" = 1'-0"